


- ELECTRICAL SHUT OFF
- GAS SHUT OFF -  
FOR SITE AT 34TH STREET
- WATER SHUT OFF -  
FOR SITE AT 34TH STREET
- SEWER CLEAN OUTS/  
SEWER PUMP
- FIRE ALARM PANEL
- TOOLS IN CUSTODIAL  
ROOM AT BUILDING A

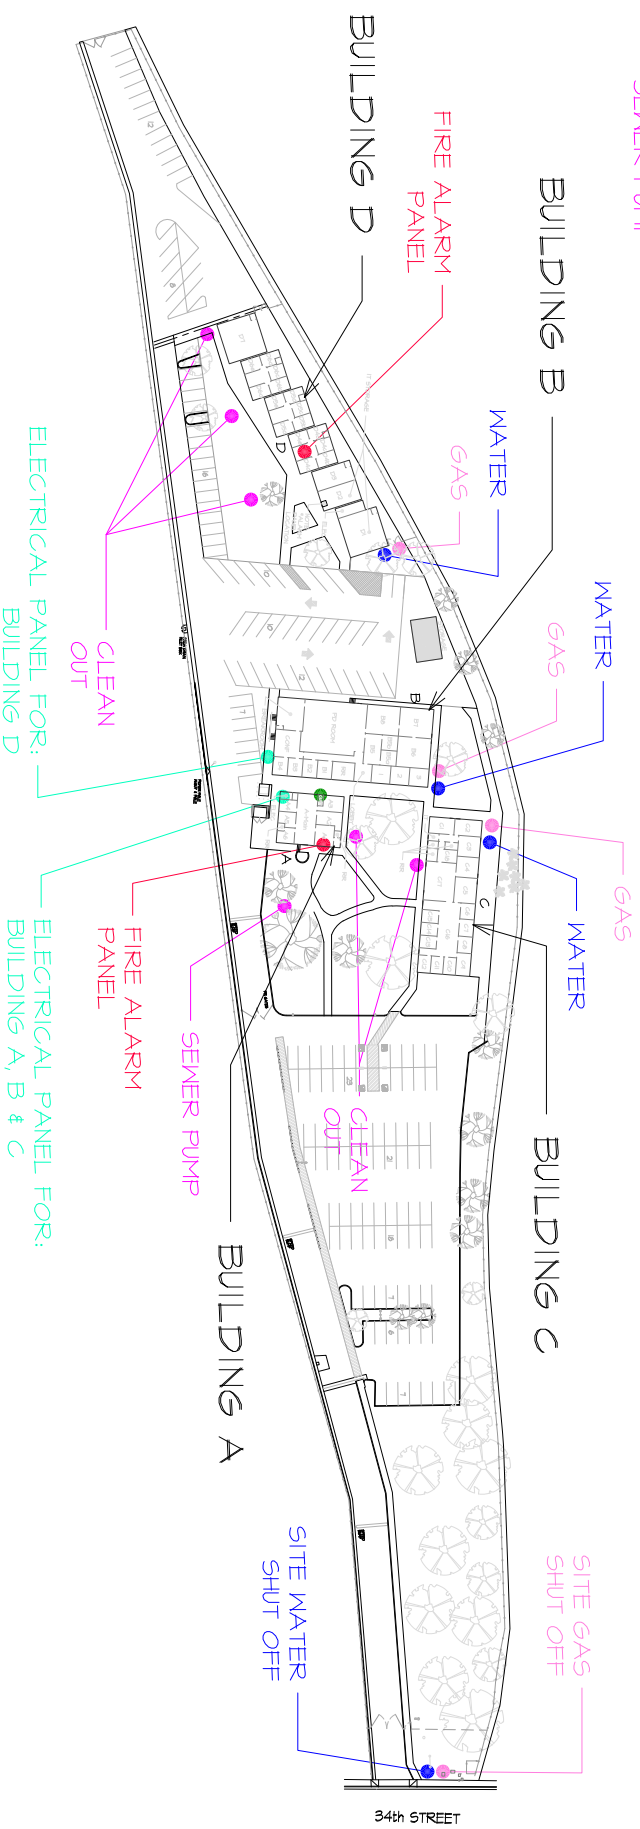


SPECIAL EDUCATION AND SCHOOL HEALTH SERVICES & WELLNESS  
222 34TH STREET  
SP ED 631-5863 / HEALTH SERV. 631-4600

AREA = 176,418 SQ. FT.  
OR 4.05 ACRES

## SITE PLAN

09-05-24

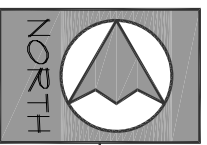

SCALE: 1"=150'