



PIPE PLAN - FIGURE 5

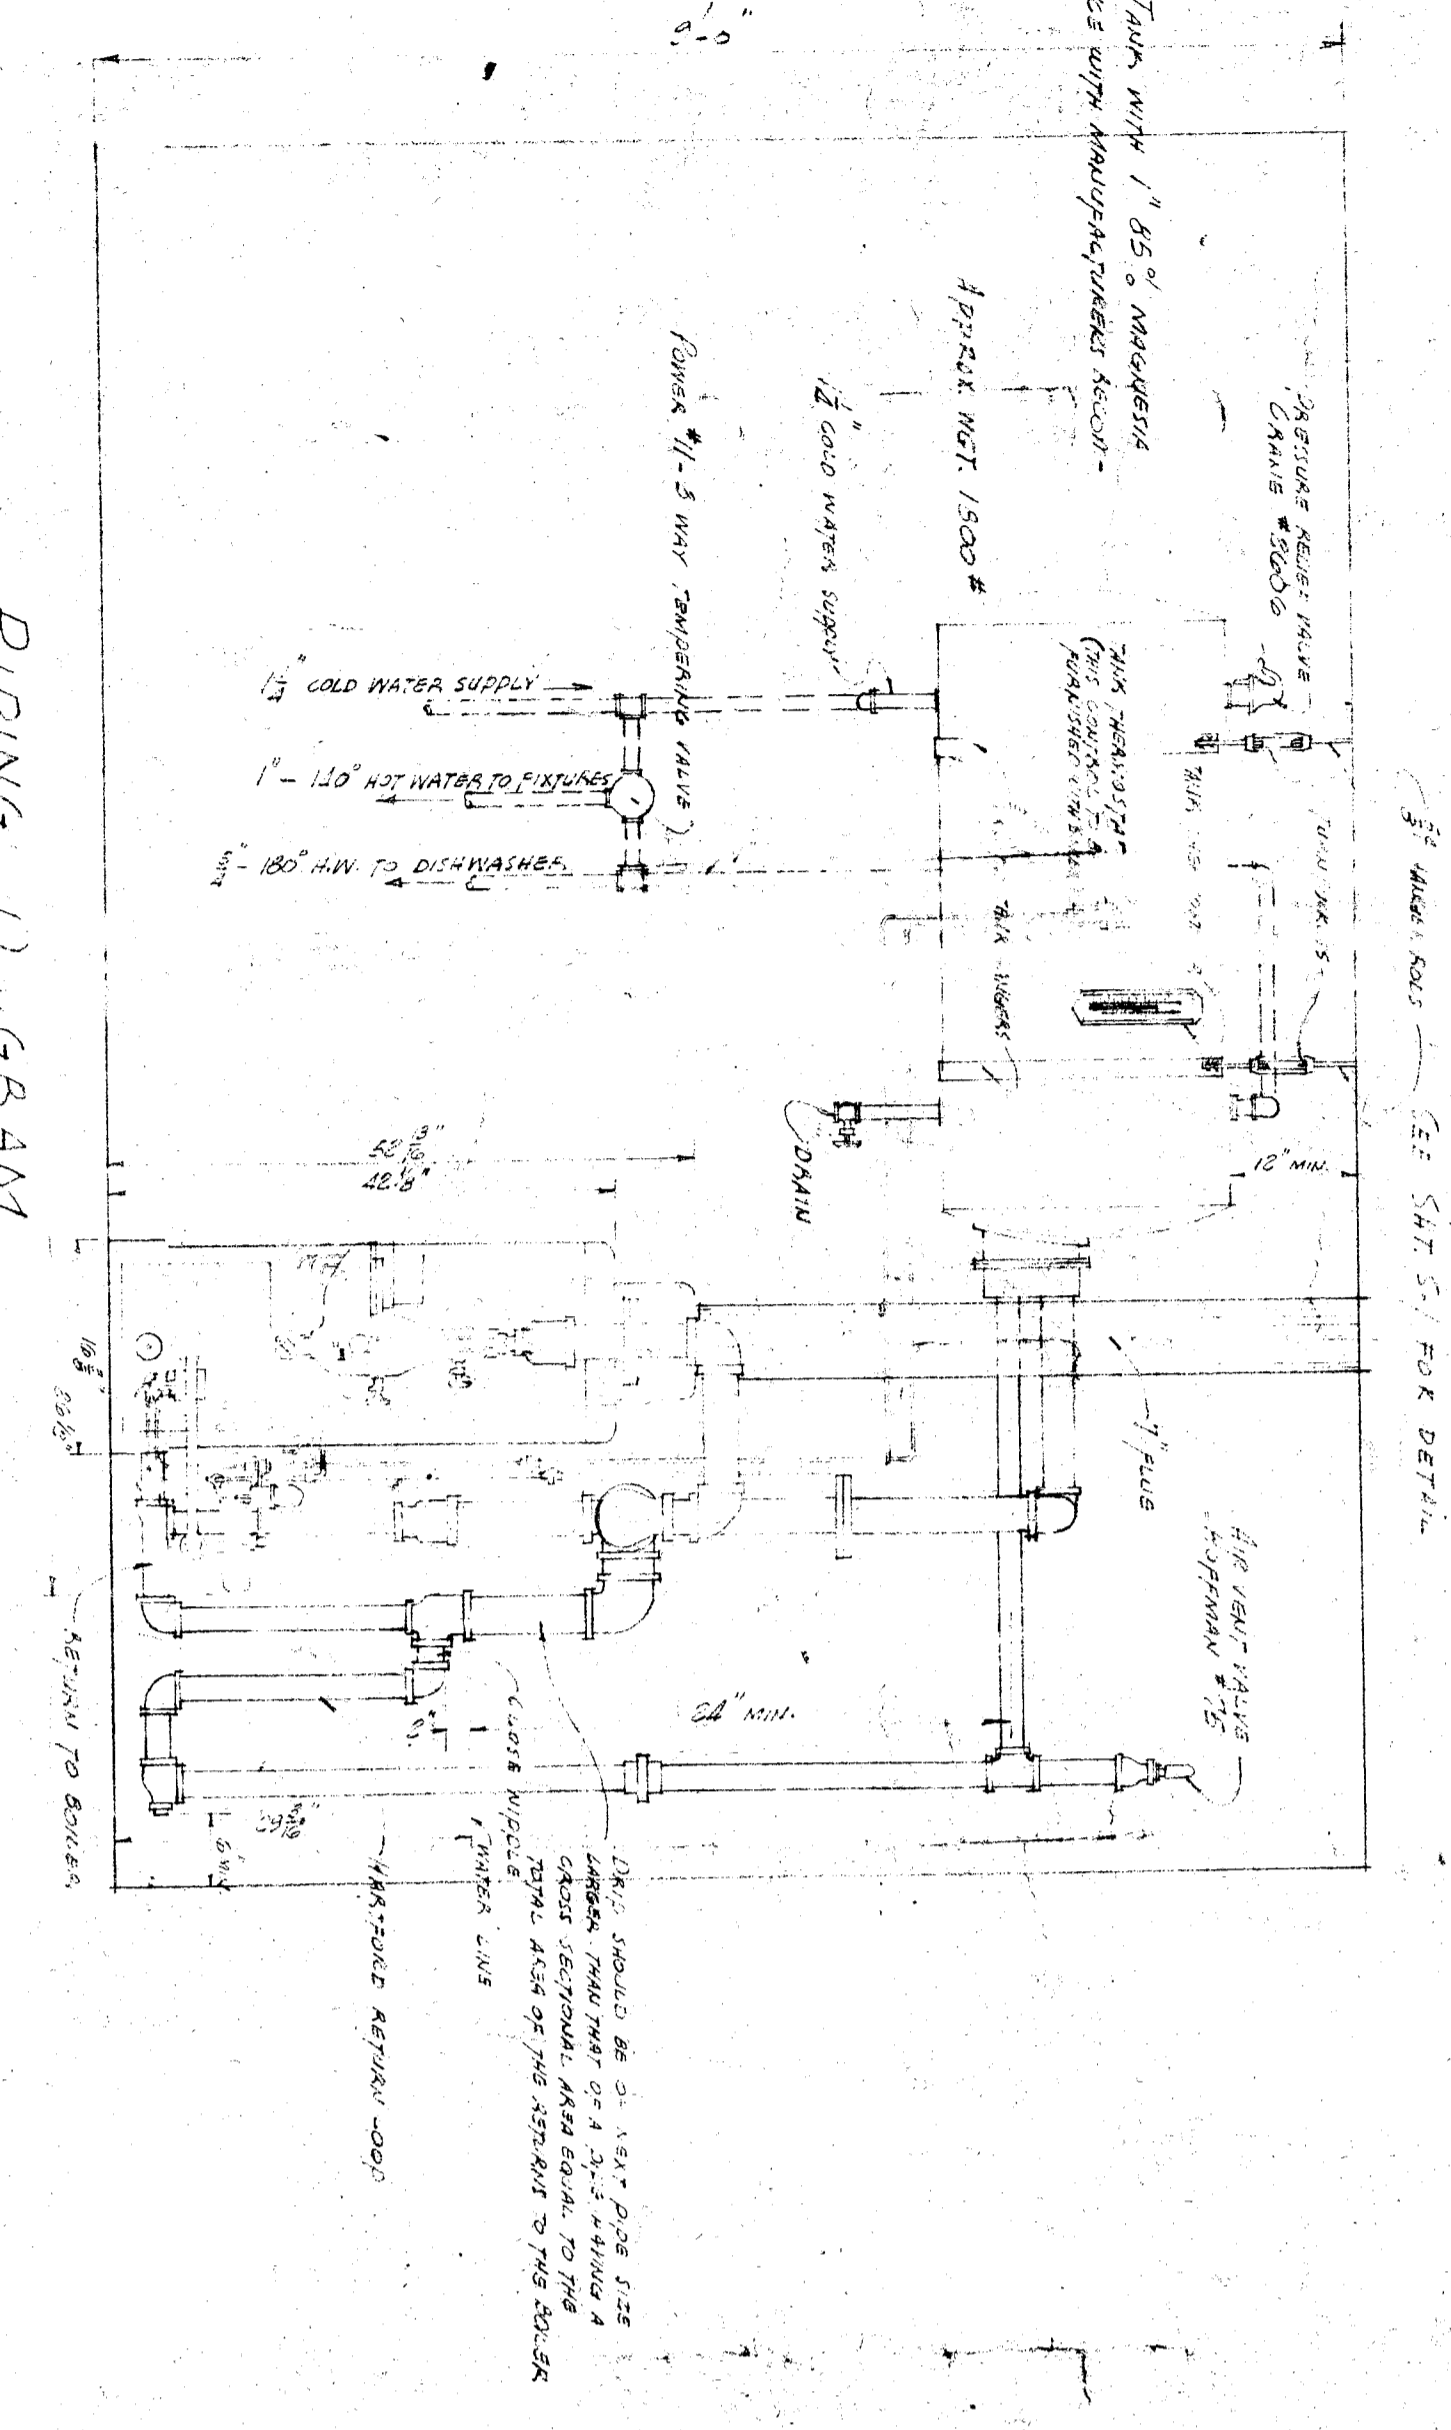


PIPE PLAN - FIGURE 6

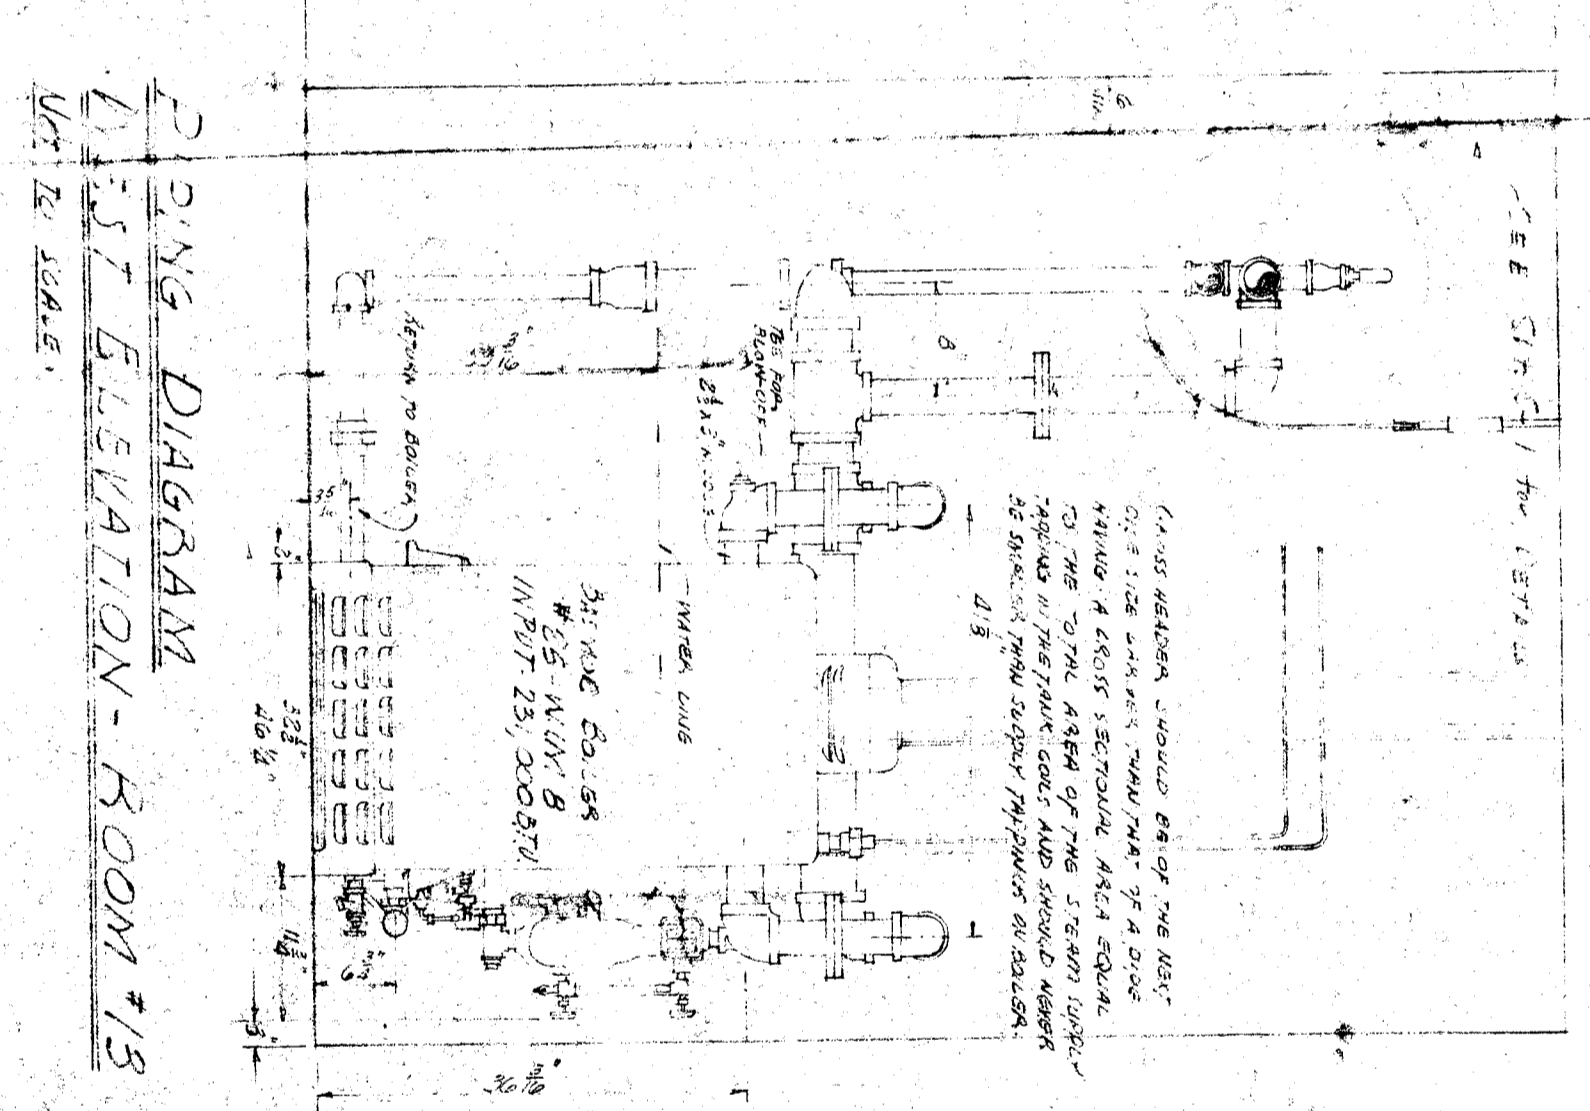

PIPE DIAGRAM - LAVATORY ROOM

REVISIONS APPROVED:
 DATE: 10-16-50
 SIGNATURE: [Handwritten Signature]
 PROJECT: N. 5001, HAWAIIAN AIA

NOTE:
 SEE S.P. FOR DETAIL
 MAKE PIPES EXPOSED OR
 PARALLEL TO FLOOR

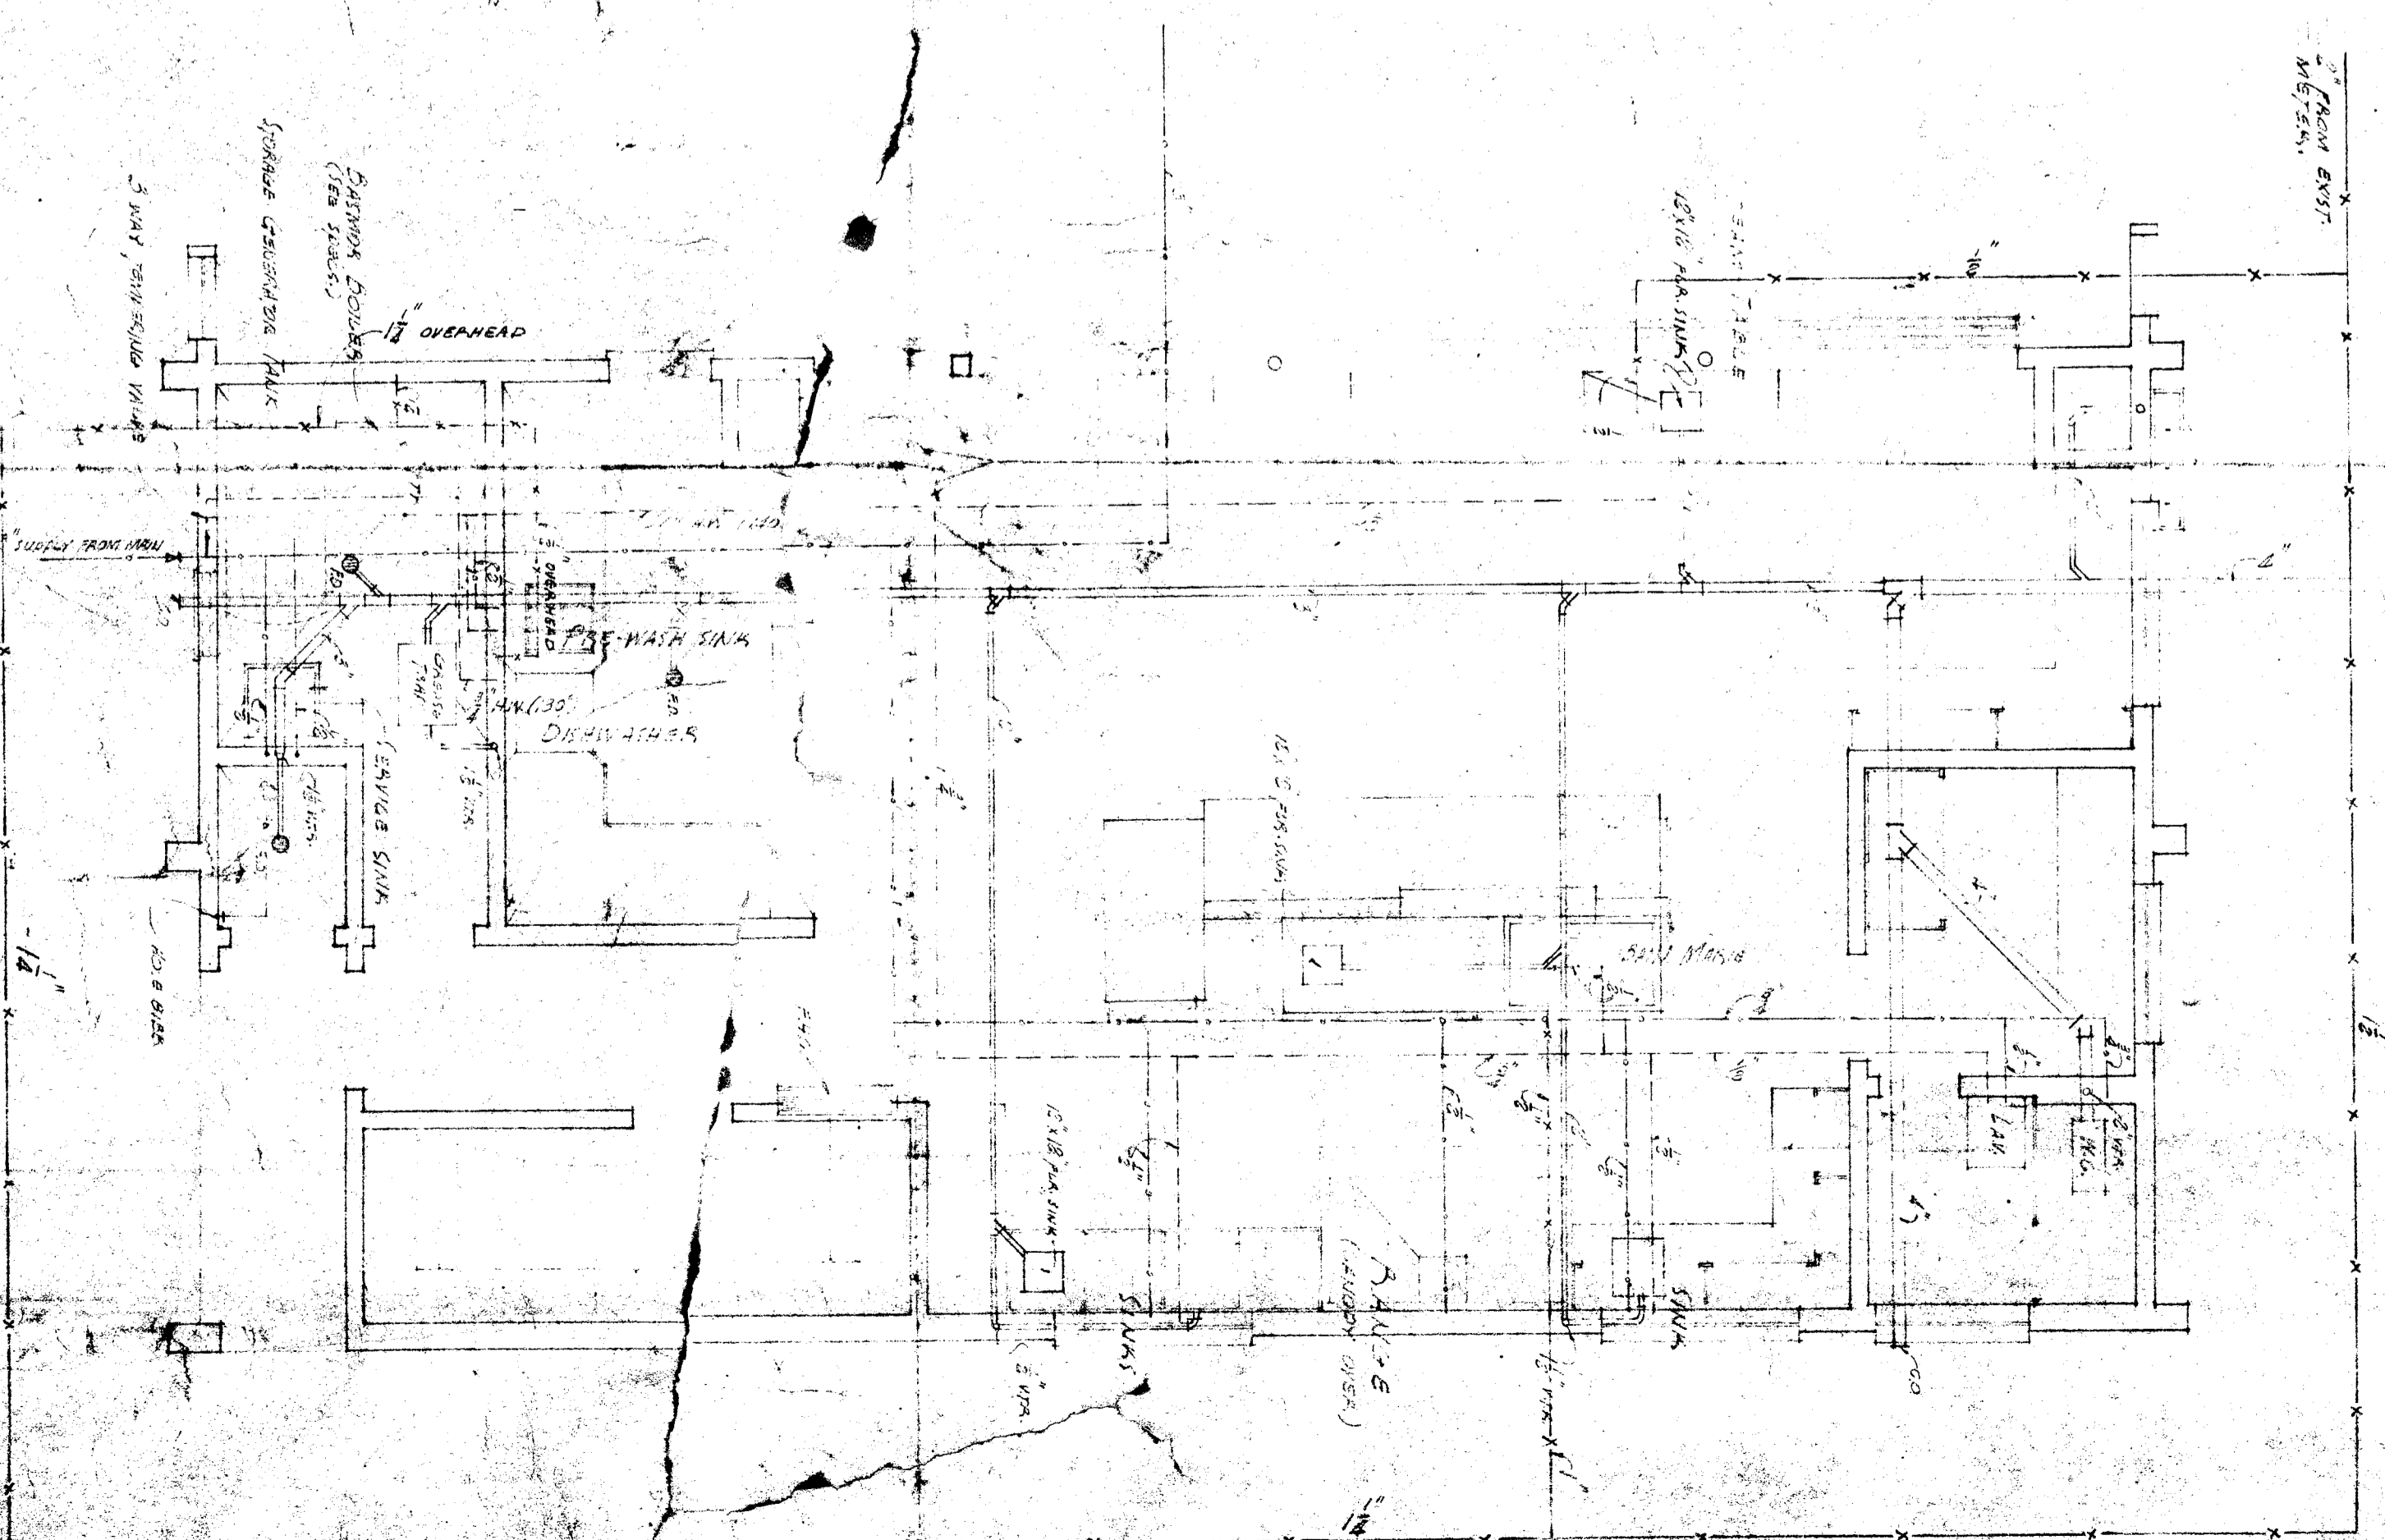

PIPE PLAN OF KITCHEN

SITE OF CITY OF HONOLULU
 DIVISION OF CIVIL ENGINEERING
 PROJECT: N. 5001, HAWAIIAN AIA
 DATE: 10-16-50

DESIGNED BY: [Handwritten Signature]
 DRAWN BY: [Handwritten Signature]

REVISIONS	DATE	BY	REASON
1	10-16-50	[Handwritten Signature]	MECHANICAL LAYOUT & DETAILS