


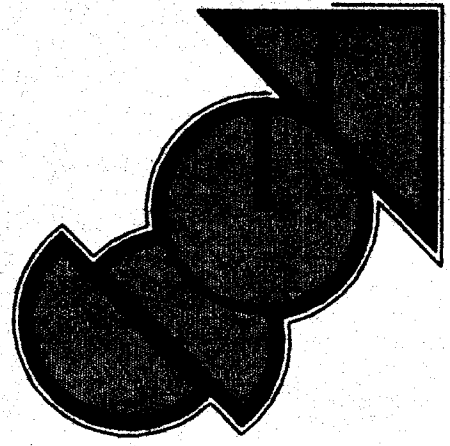

SCA Architect, Inc.
1301 L Street
Bakersfield, CA 93301
(805) 327-1632



Stephen A. Pappas, P.E.
Bakersfield, CA 93301, USA

INVESTIGATION STAMP
DIV. OF THE STATE ARCHITECT
OFFICE OF REGULATION SERVICES
APPL. 03-1902971
Page 15-6
AC 100-15.5 & 15.8 MC
DATE SENT 02-28-2008

A NEW TOILET BUILDING
AT FREMONT AND MT. VERNON
607 TEXAS ST. AND 2161 POTOMAC AVE.
BAKERSFIELD CITY SCHOOL DISTRICT
BAKERSFIELD, KERN COUNTY, CALIFORNIA



PLUMBING &
MECHANICAL
FLOOR PLANS

CHECK AND VERIFY ALL DIMENSIONS
BEFORE PROCEEDING WITH THE
WORK. REPORT DISCREPANCIES
TO THE ARCHITECT. ALL
CONSTRUCTION SHALL CONFORM
TO THE C.S.C.


MARK	DATE	REVISIONS
Δ		
Δ		
Δ		
Δ		

JOB NO. 970
DRAWN: MJS/SA
CHECKED: MJS/SA
DATE: 9/4/99
2 OF 2 SHEETS


MECHANICAL FLOOR PLAN - MT. VERNON
SCALE: 1/4" = 1'-0"
MECHANICAL ENGINEERING SERVICES
1301 L STREET
BAKERSFIELD, CA 93301
Tel: (805) 327-1632 Fax: (805) 327-1699
PLOTTED 1/05/00
MDC
MECHANICAL DESIGN CONCEPTS

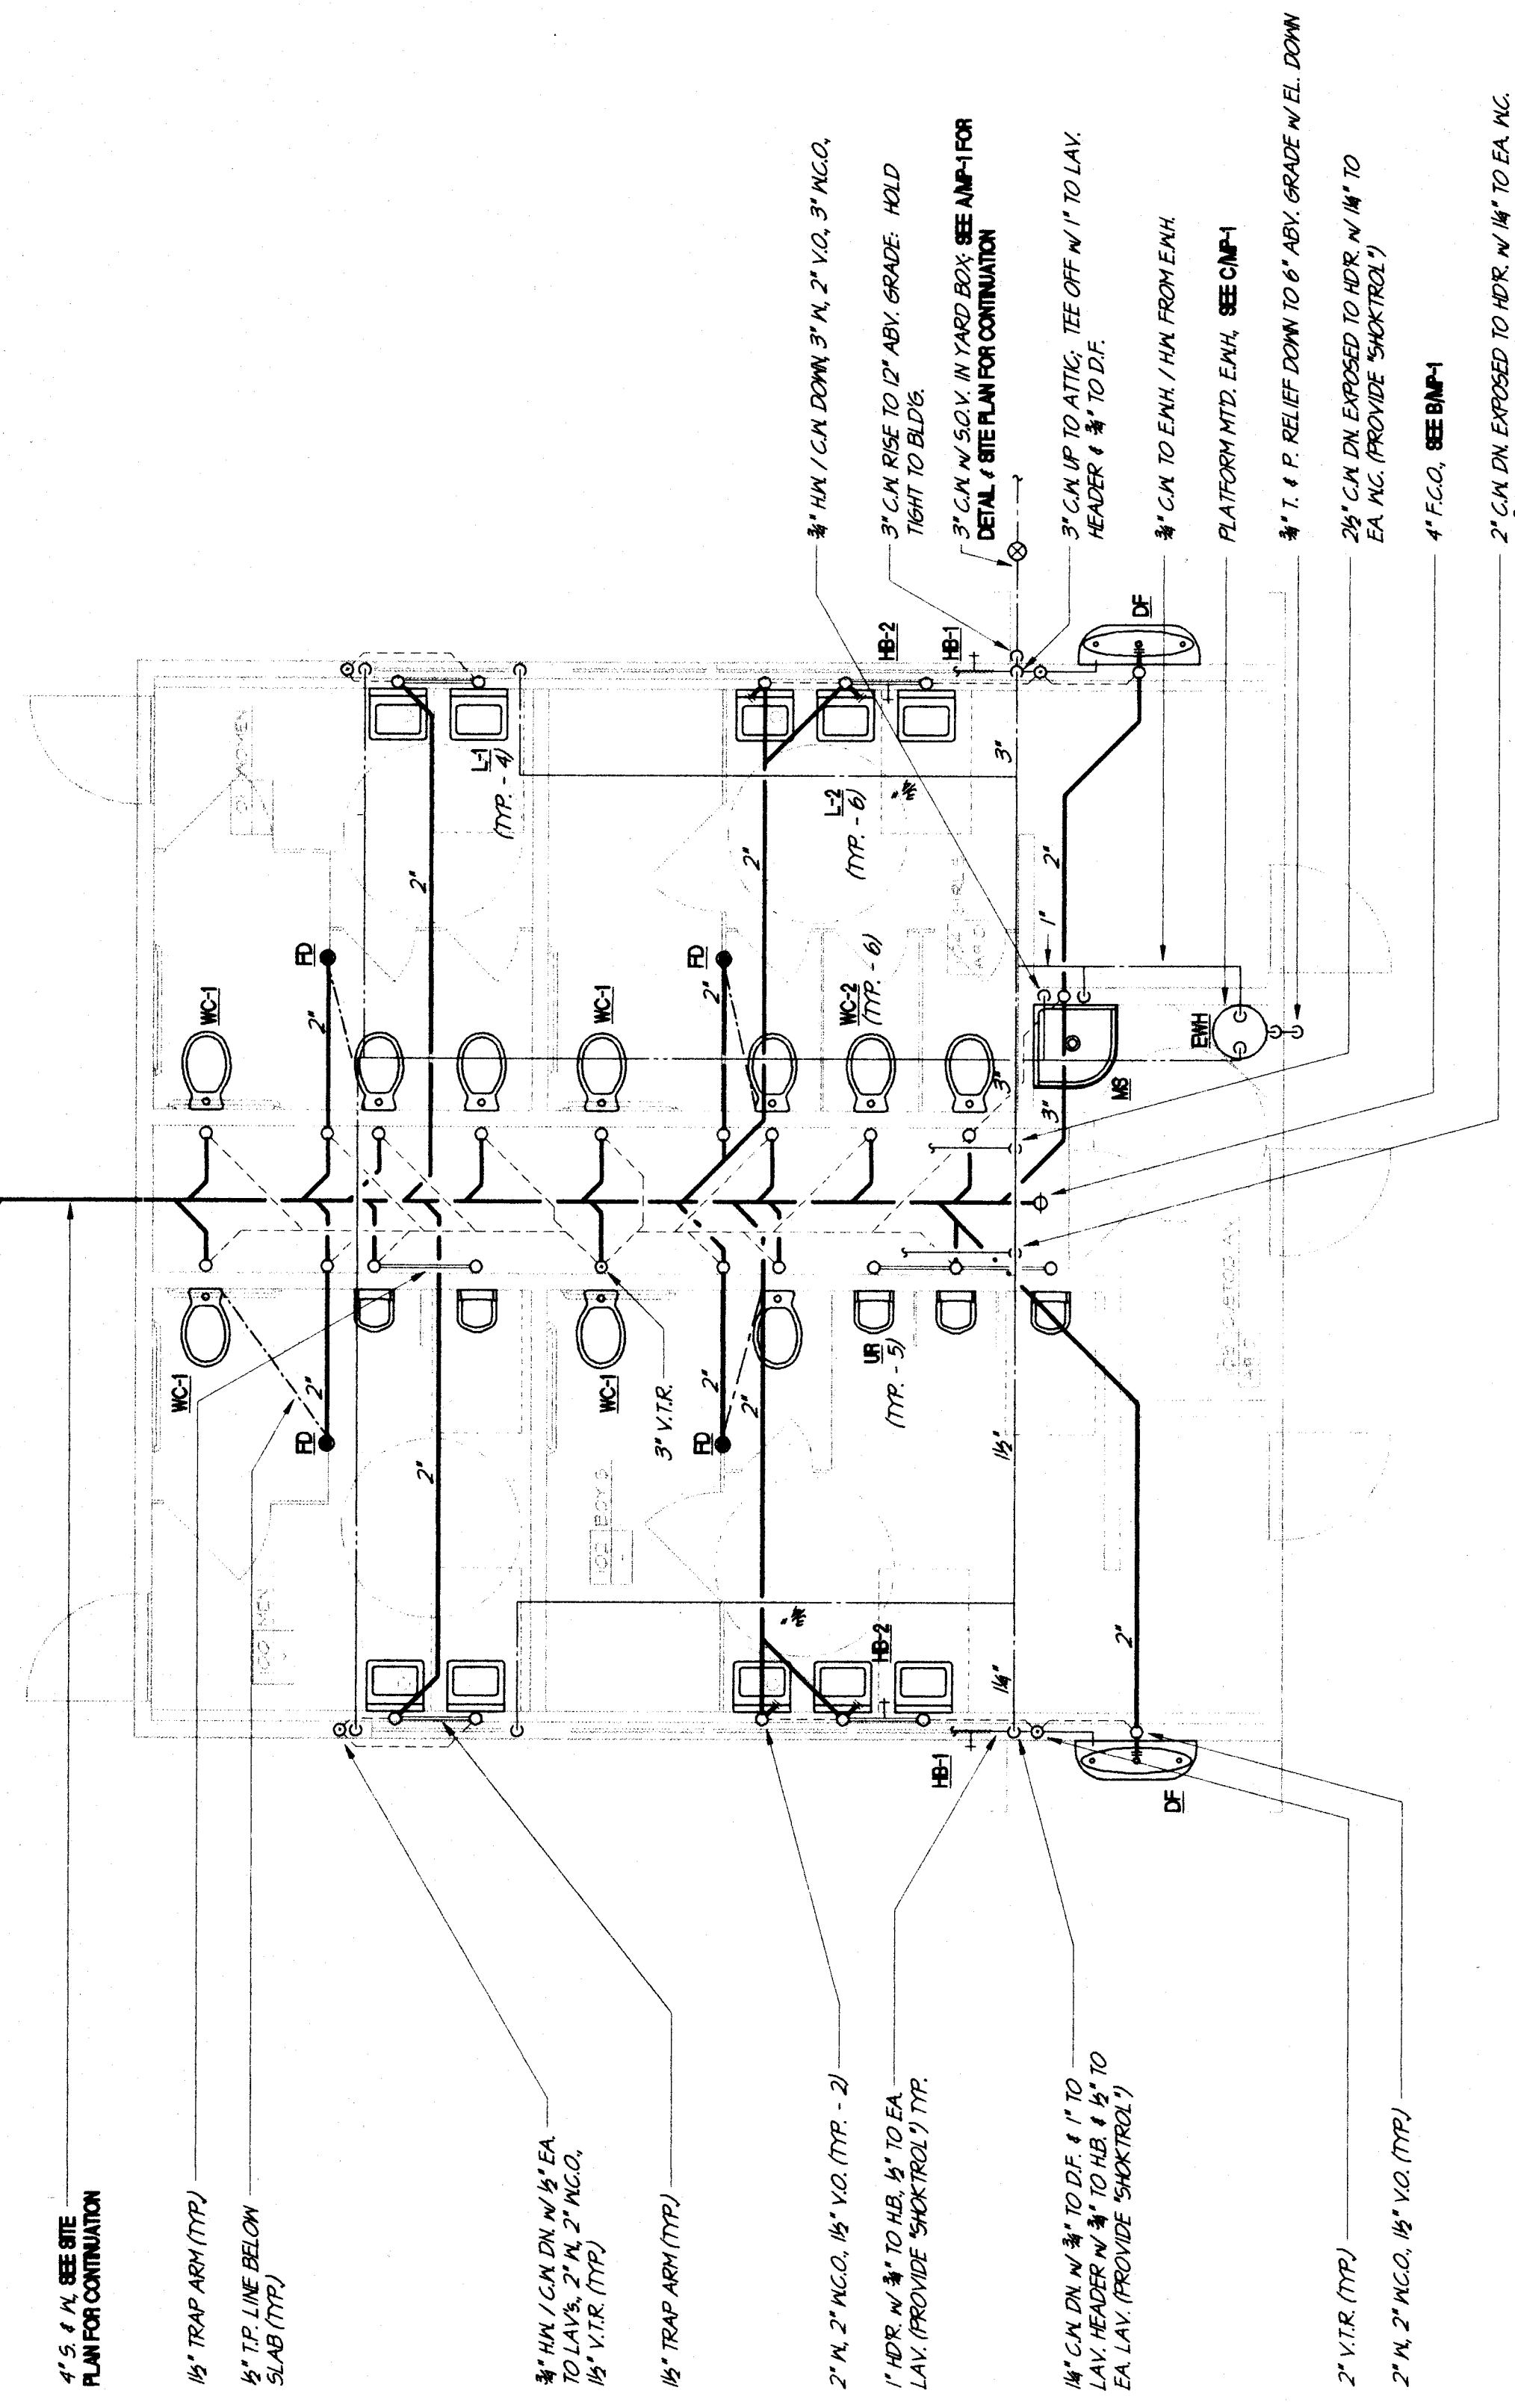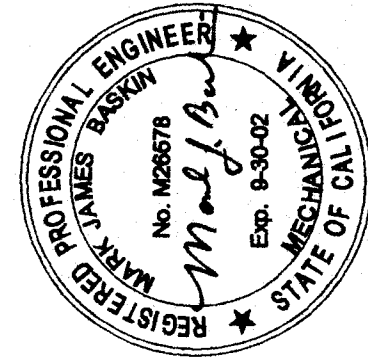

PLUMBING FLOOR PLAN - MT. VERNON
SCALE: 1/4" = 1'-0"

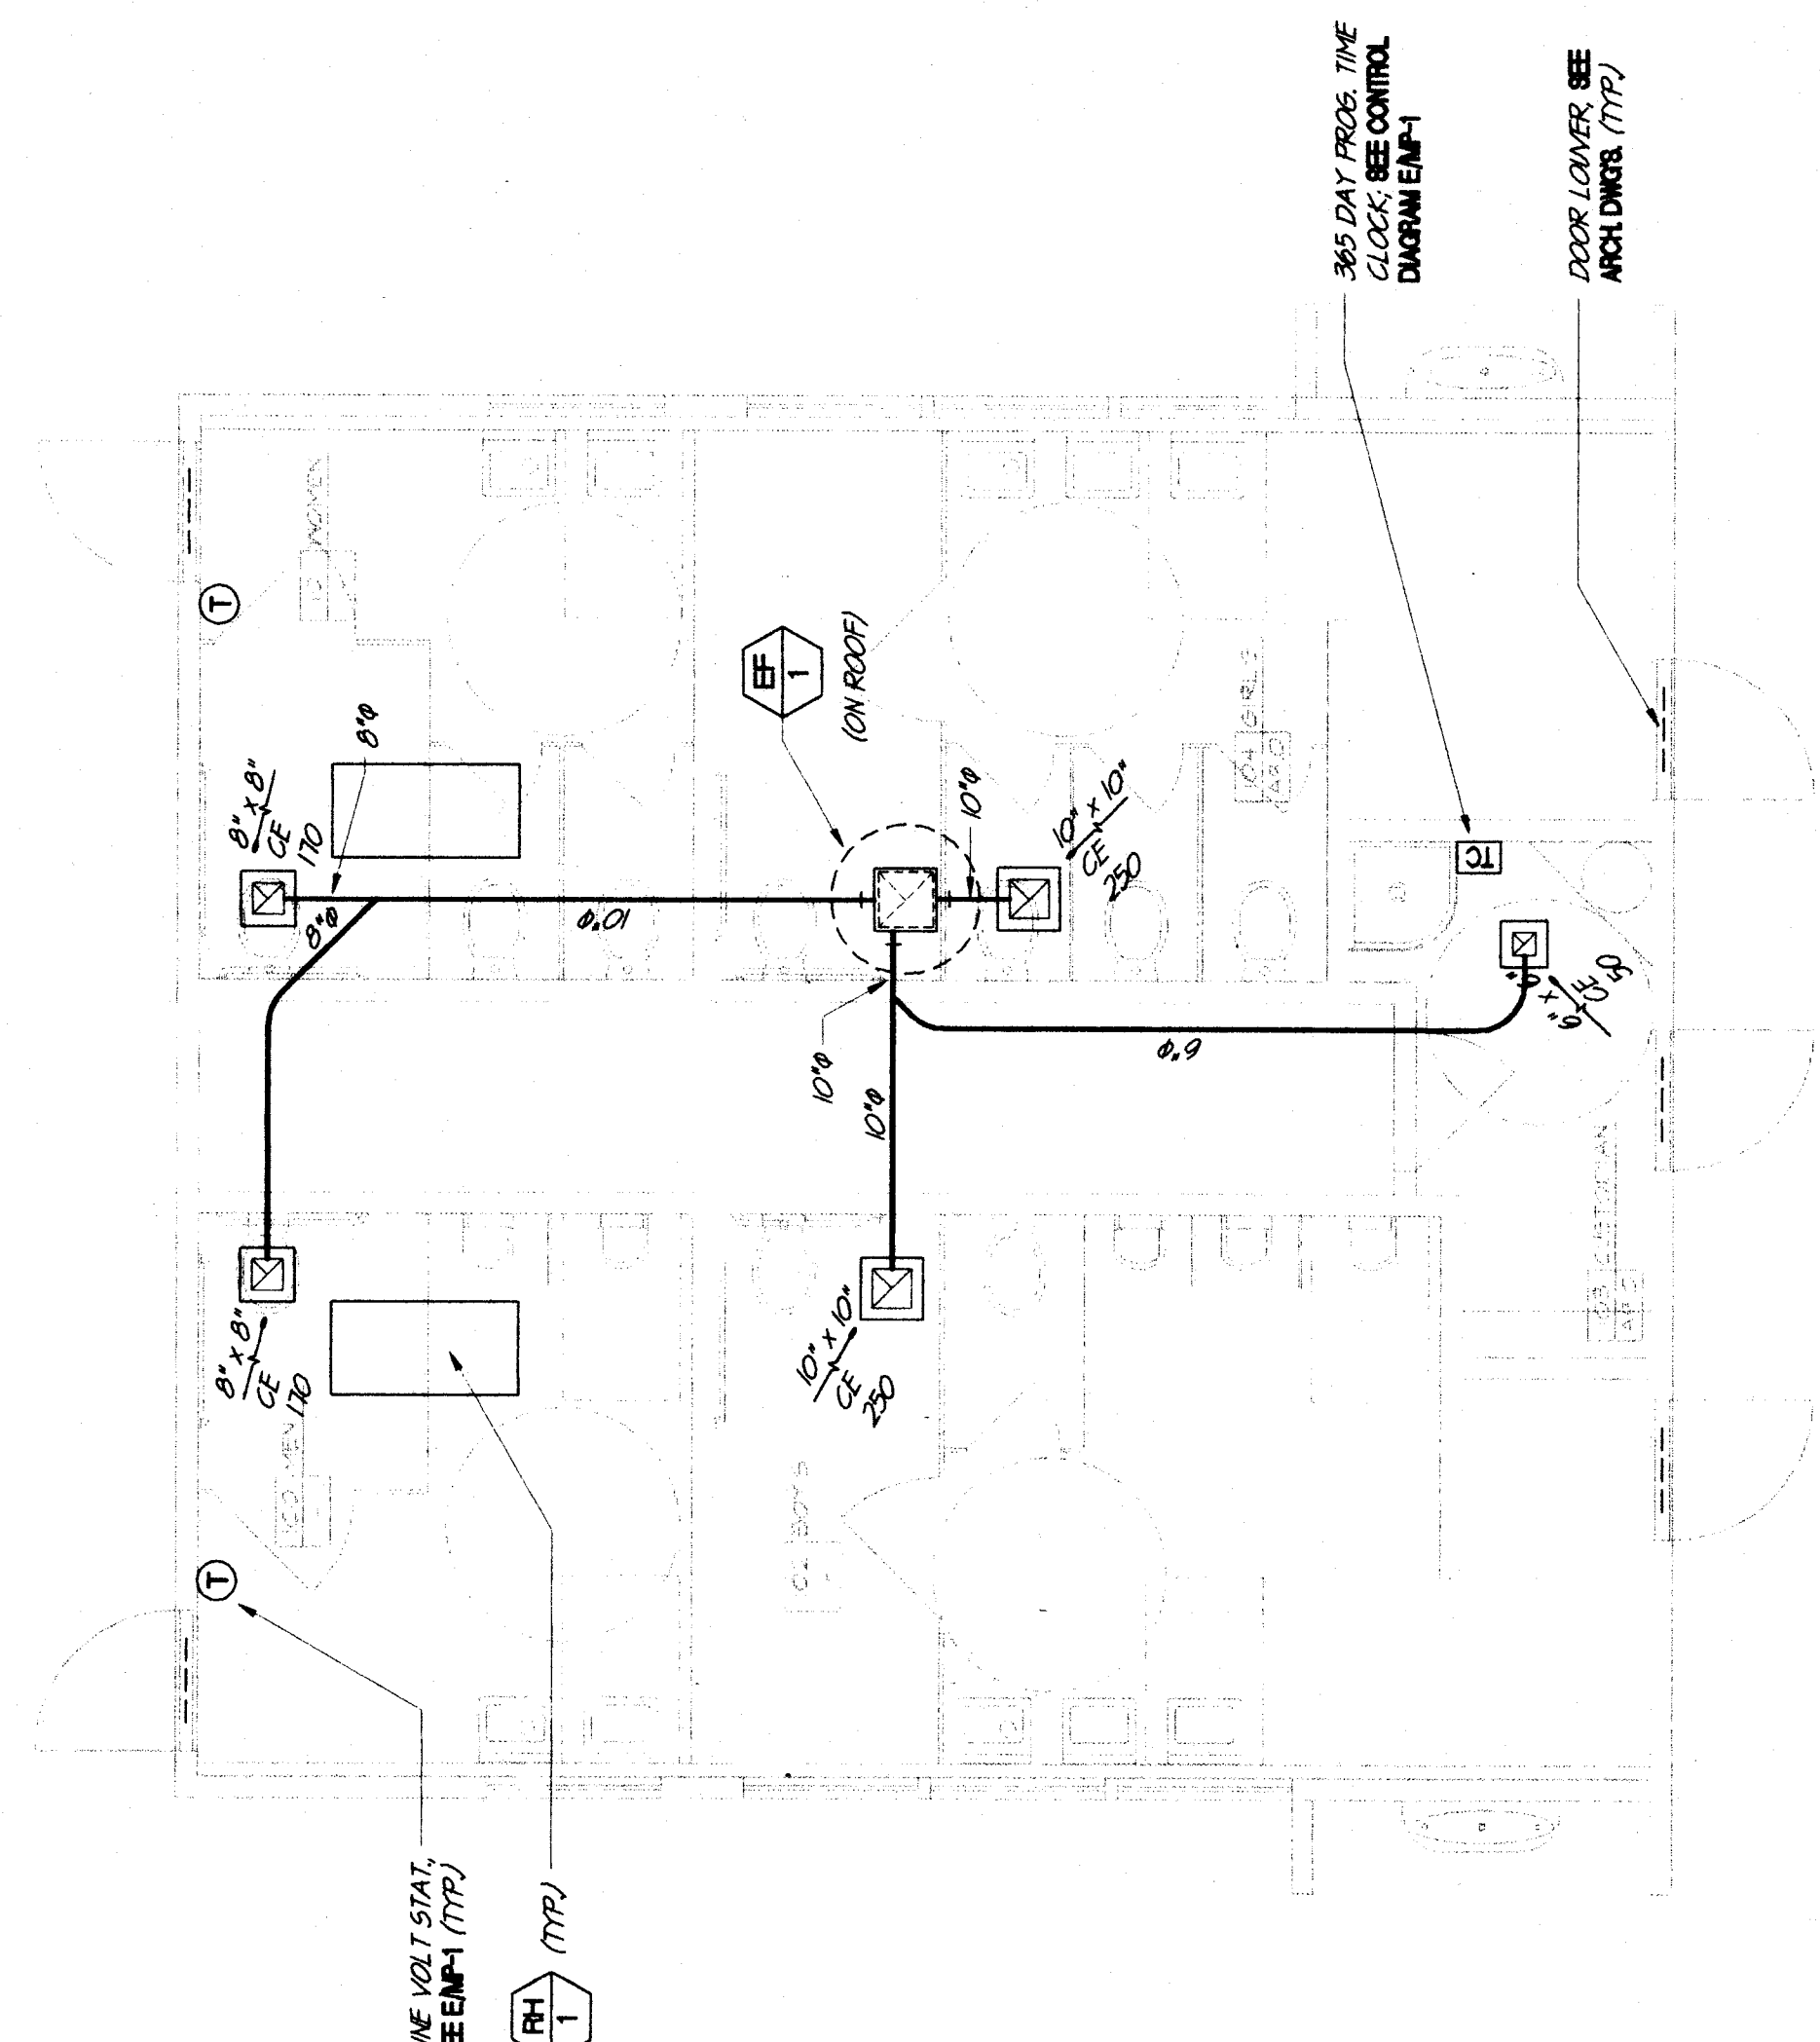

MECHANICAL FLOOR PLAN - FREMONT
SCALE: 1/4" = 1'-0"

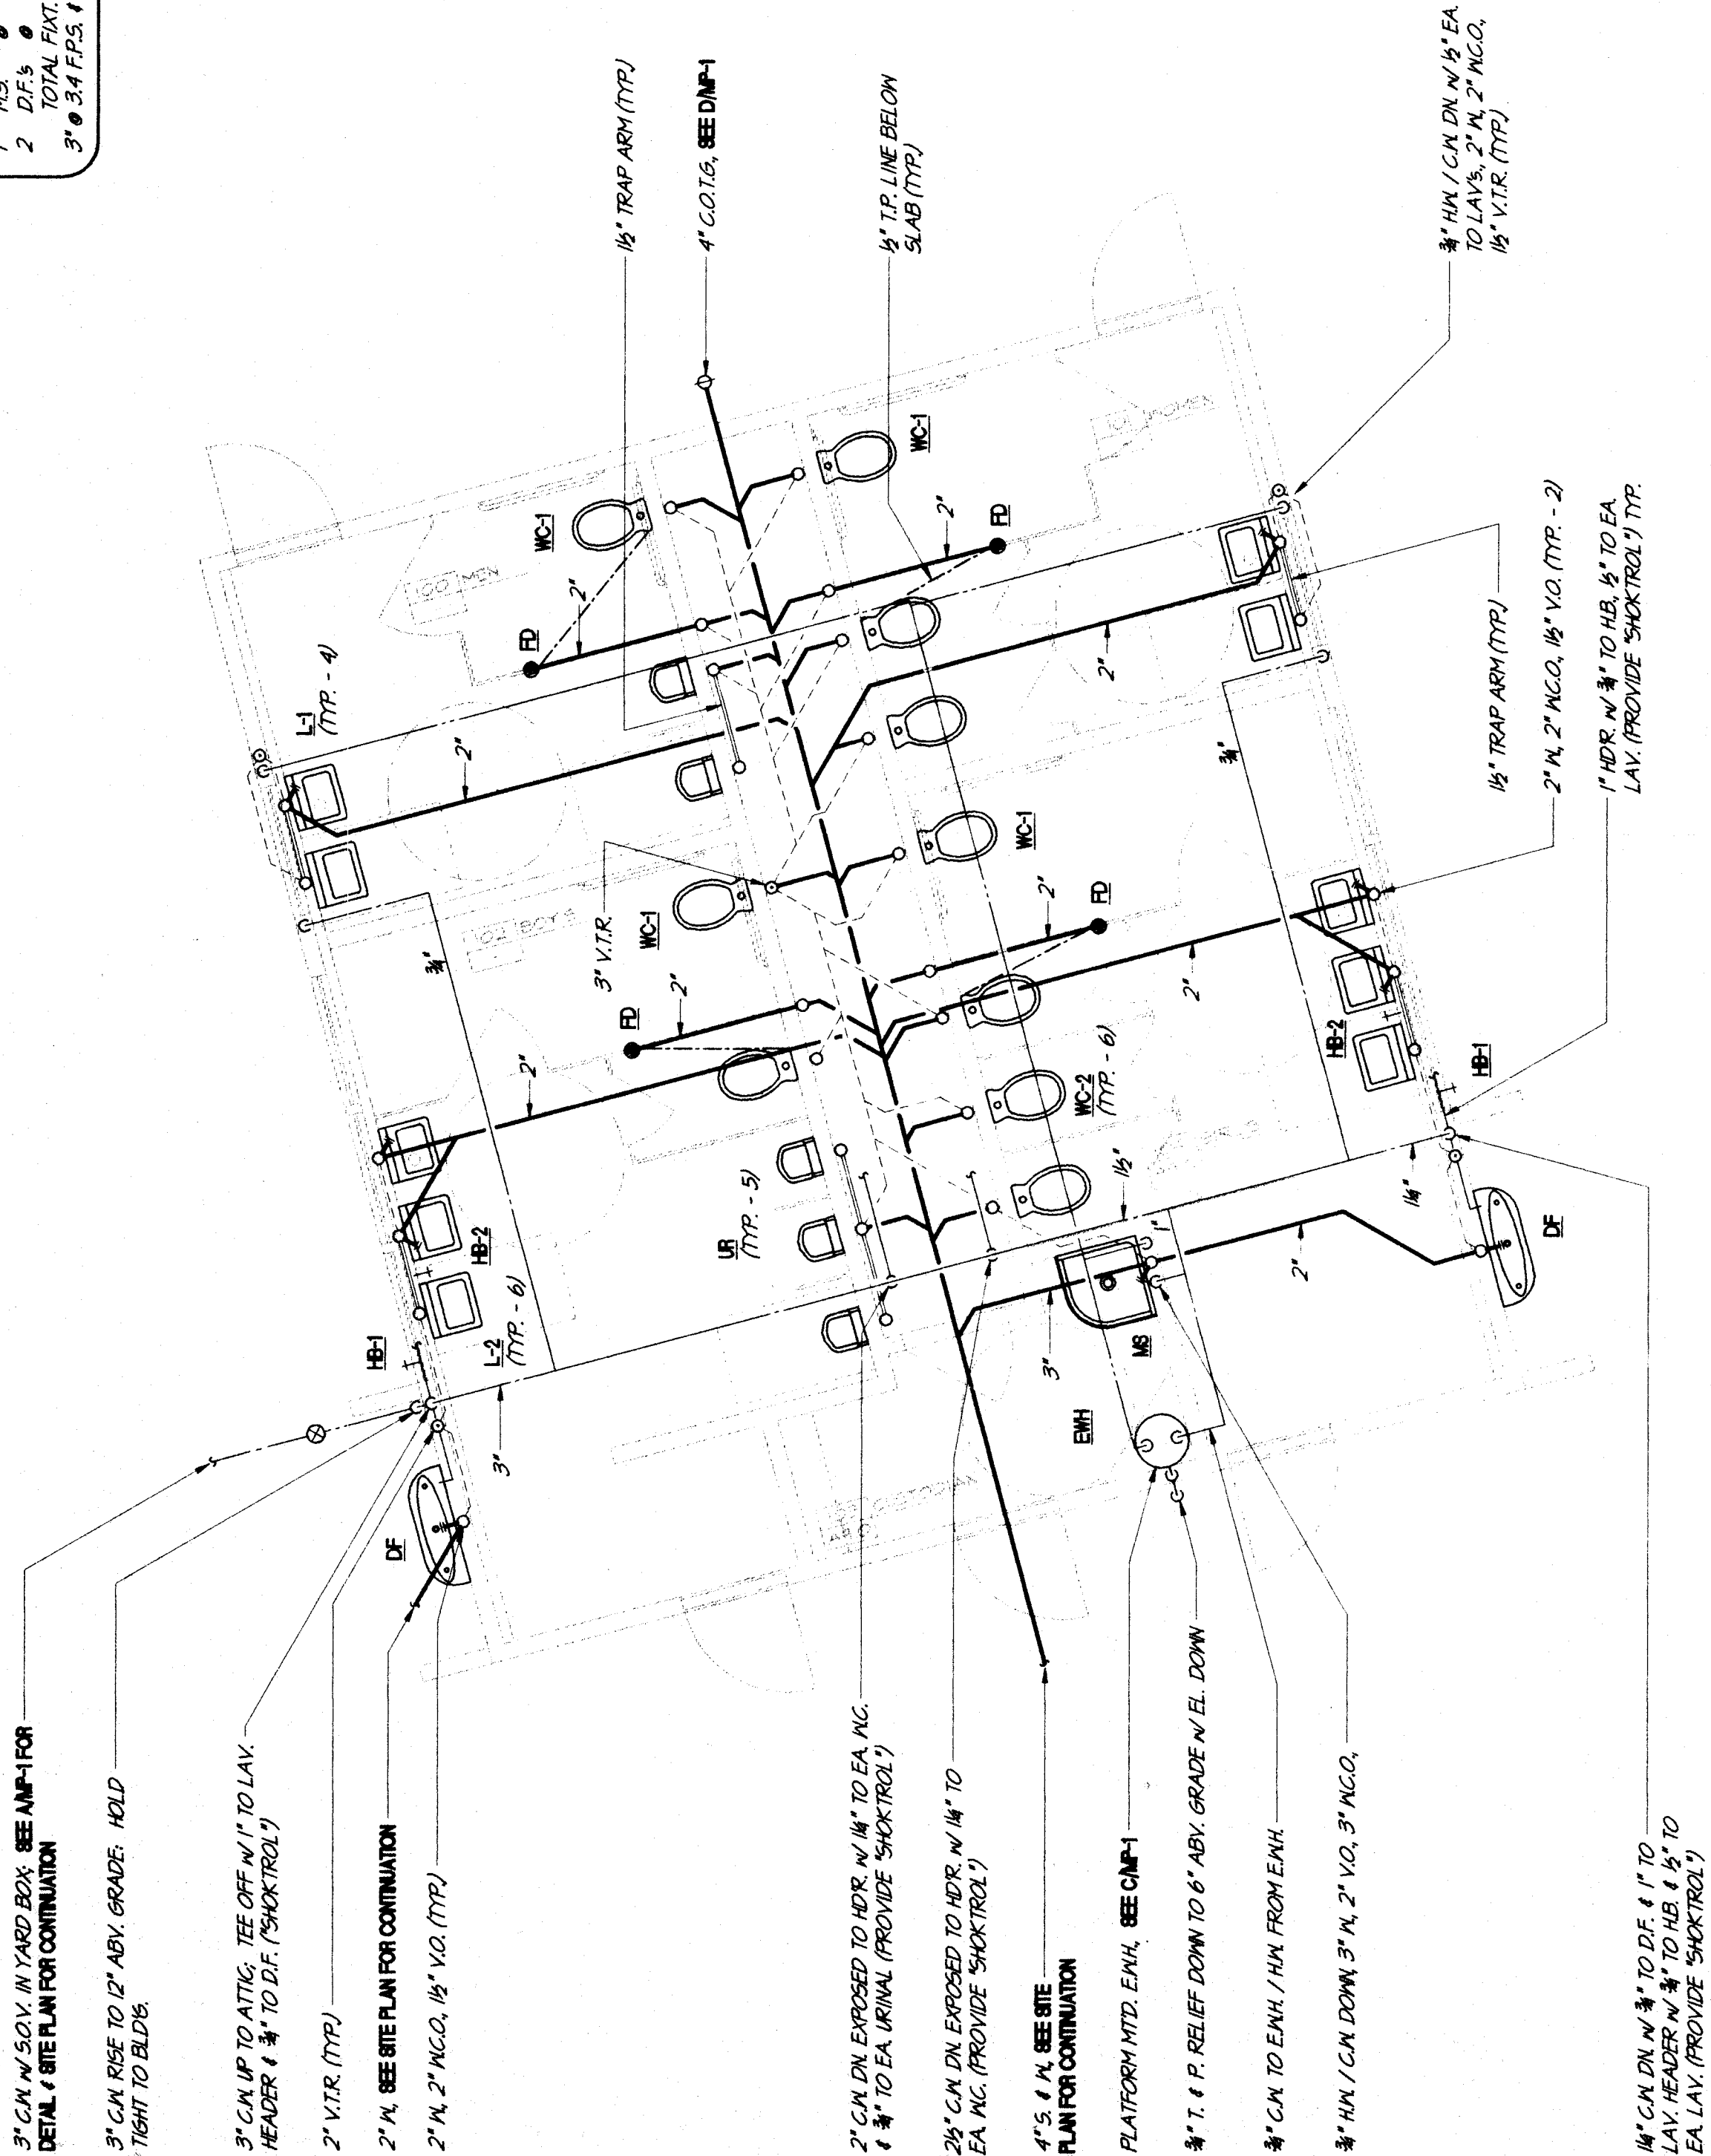

PLUMBING FLOOR PLAN - FREMONT
SCALE: 1/4" = 1'-0"

